

V1
TEST HEATER TREATER
48" DIA. x 20'-0" S/S
MAWP: 50 PSIG @ 200°F


V2
GAS SCRUBBER
3'-0"x10'-0" S/S
MAWP: 125 PSI

V5
FUEL GAS SCRUBBER
10.3/4" x 2'-6"
MAWP: 125 PSI

V3
HEATER TREATER
8'-0" x 20'-0" S/S
MAWP: 50 PSIG @ 150°F

V6
FUEL GAS SCRUBBER
10.3/4" x 2'-6"
MAWP: 125 PSI

V4
HEATER TREATER
5'-0" x 20'-0" S/S
MAWP: 75 PSIG @ 200°F

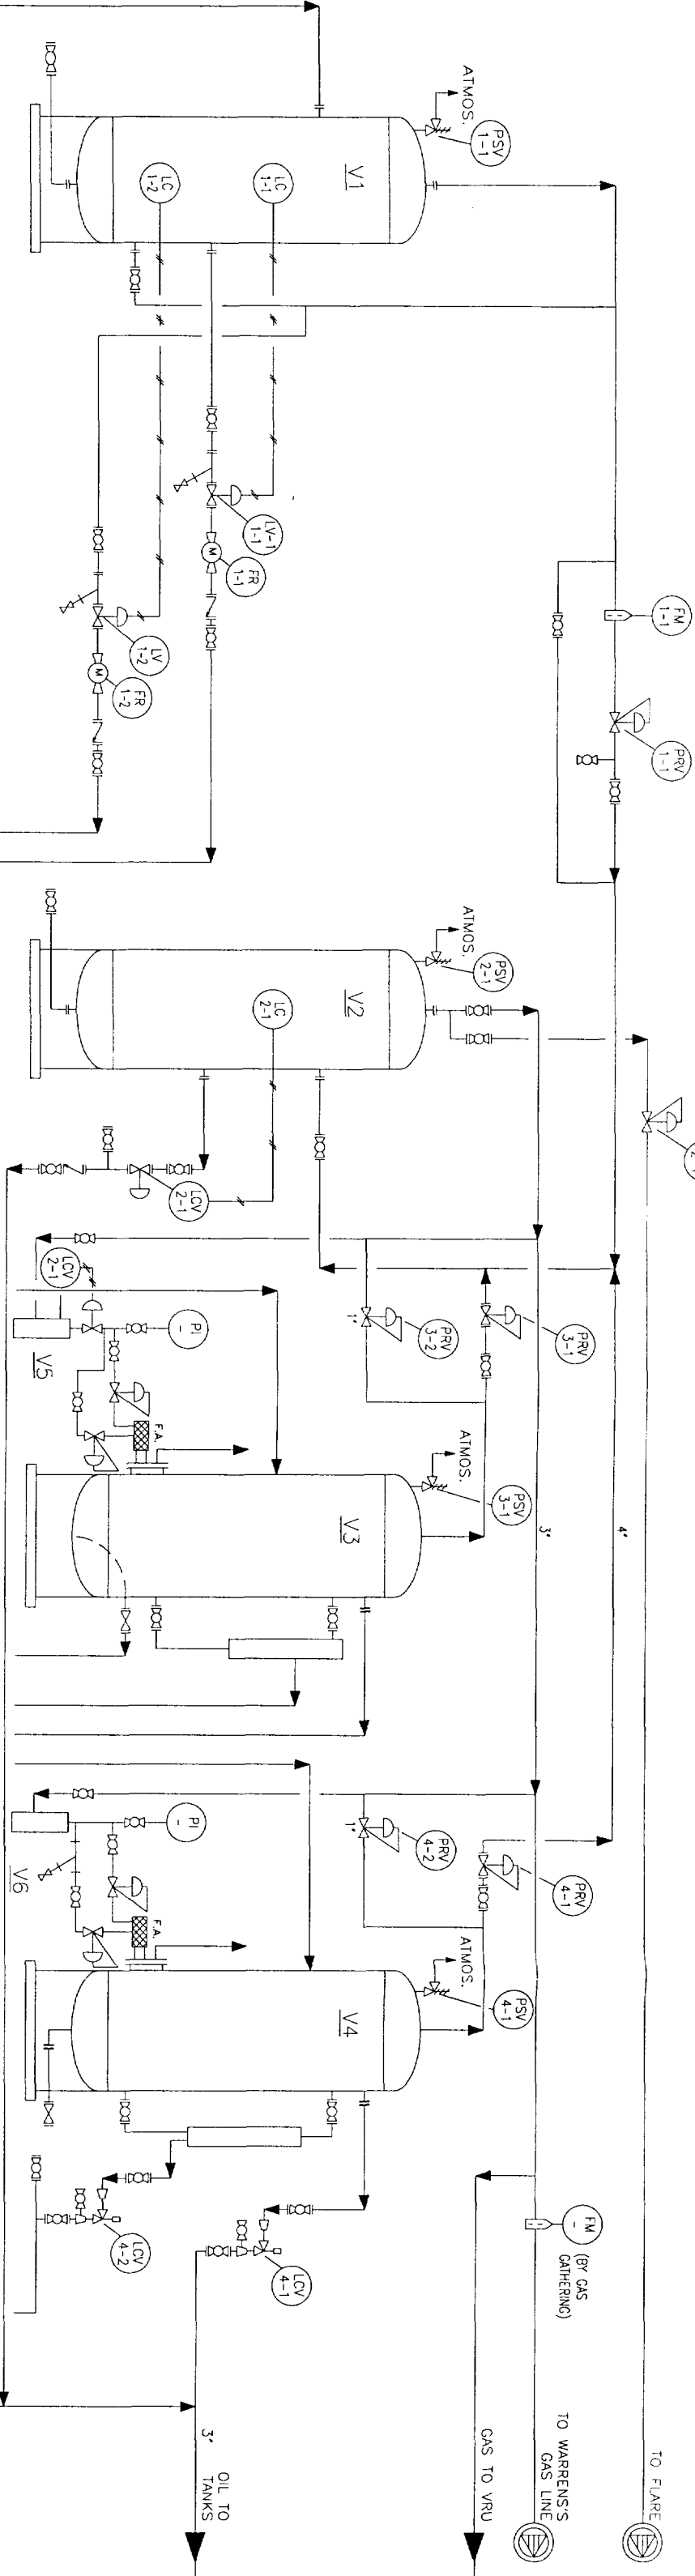


**BEFORE THE
OIL CONSERVATION DIVISION**
Santa Fe, New Mexico

Case No. 12102 Exhibit No. 6

Submitted by: Chevron U.S.A. Inc.

Hearing Date: December 17, 1998

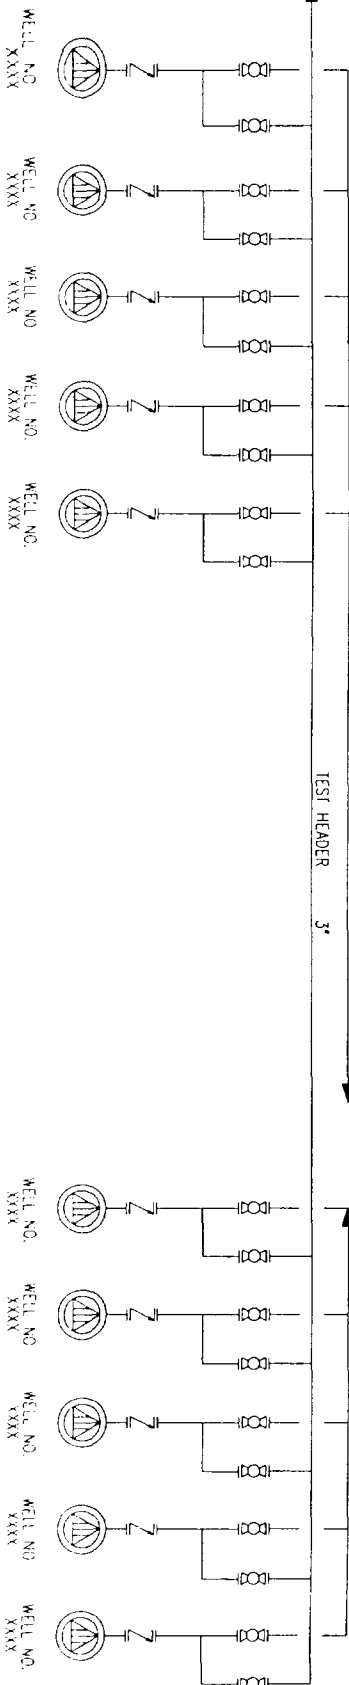

REVISIONS			
NO.	DATE	DESCRIPTION	BY
1	12/4/97	ISSUED FOR APPROVAL	JAV
2	12/8/97	ISSUED FOR APPROVAL	JAV



Chevron U.S.A. Inc.
Permian Oil & Gas Profit Centers

MONUMENT NORTH ABO FIELD
MONUMENT STATE 12A COMCI
TEST SEPARATOR, GAS SCRUBBER, HEATERS, AND PRODUCTION MANIFOLDS
PIPING & INSTRUMENTATION DIAGRAM
Lao County,
New Mexico

ENGINEERING	DATE	SCALE
DESIGNED BY	12/4/97	NONE
DRAWN BY	12/4/97	NONE
CHECKED BY	12/4/97	NONE
APPROVED BY	12/4/97	NONE