


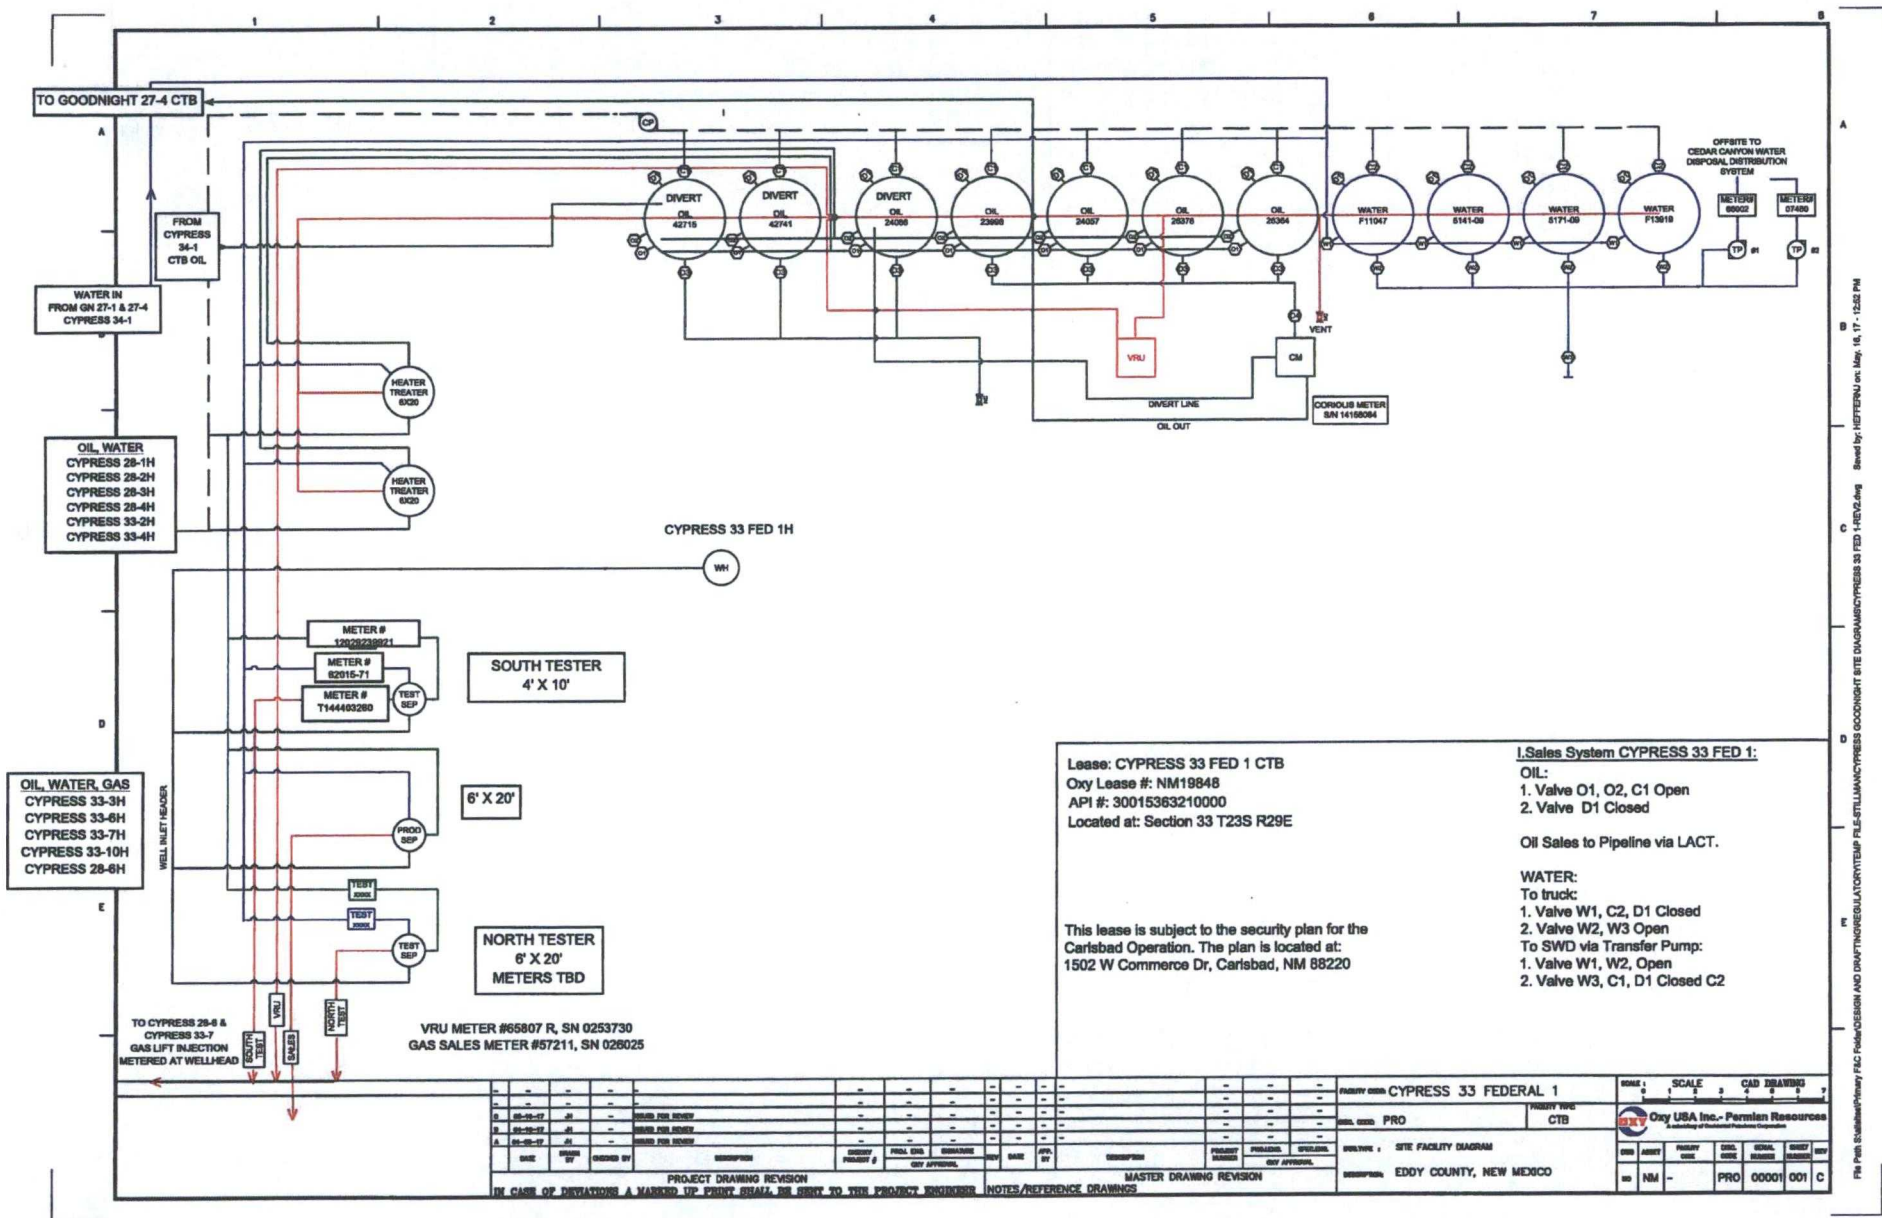

Lease: CYPRESS 33 FED 1 CTB
Oxy Lease #: NM19848
API #: 30015363210000
Located at: Section 33 T23S R29E

- 1. Sales System CYPRESS 33 FED 1:**
- OIL:**
- 1. Valve O1, O2, C1 Open
 - 2. Valve D1 Closed
- Oil Sales to Pipeline via LACT.**
- WATER:**
- To truck:**
- 1. Valve W1, C2, D1 Closed
 - 2. Valve W2, W3 Open
- To SWD via Transfer Pump:**
- 1. Valve W1, W2, Open
 - 2. Valve W3, C1, D1 Closed C2

This lease is subject to the security plan for the Carlsbad Operation. The plan is located at: 1502 W Commerce Dr, Carlsbad, NM 88220

																				PROJECT NO. CYPRESS 33 FEDERAL 1										SCALE: 0 1 2 3 4 5 6 7									
																				SHEET NO. PRO										PROJECT NAME: CTB									
																				SHEET NO. PRO										PROJECT NAME: CTB									
																				SHEET NO. PRO																			

File Path: S:\drawings\primary FAC Plans\DESIGN AND DRAFTING\REGULATORY\TEMP FILE\STILLMAN\CYPRESS 33 FED 1\REV2.dwg Saved by: HEFFERNAN on May 16, 17 - 1:52 PM