


MARATHON OIL COMPANY
SERVING WELLS: NIBU 1, 4, 5, 8, 9, 31, 34 & 36
STATION NO: 210
660' FSL & 660' FWL
SEC. 10, T-21-S, R-23-E
NM 05608
EDDY CO. N.M.

THE FACILITY IS SUBJECT
TO THE SITE SECURITY PLAN FOR
THE INDIAN BASIN FIELD. THE
PLAN IS LOCATED AT:
MARATHON OIL CO.
329 MARATHON RD.
LAKEWOOD, NM 88259

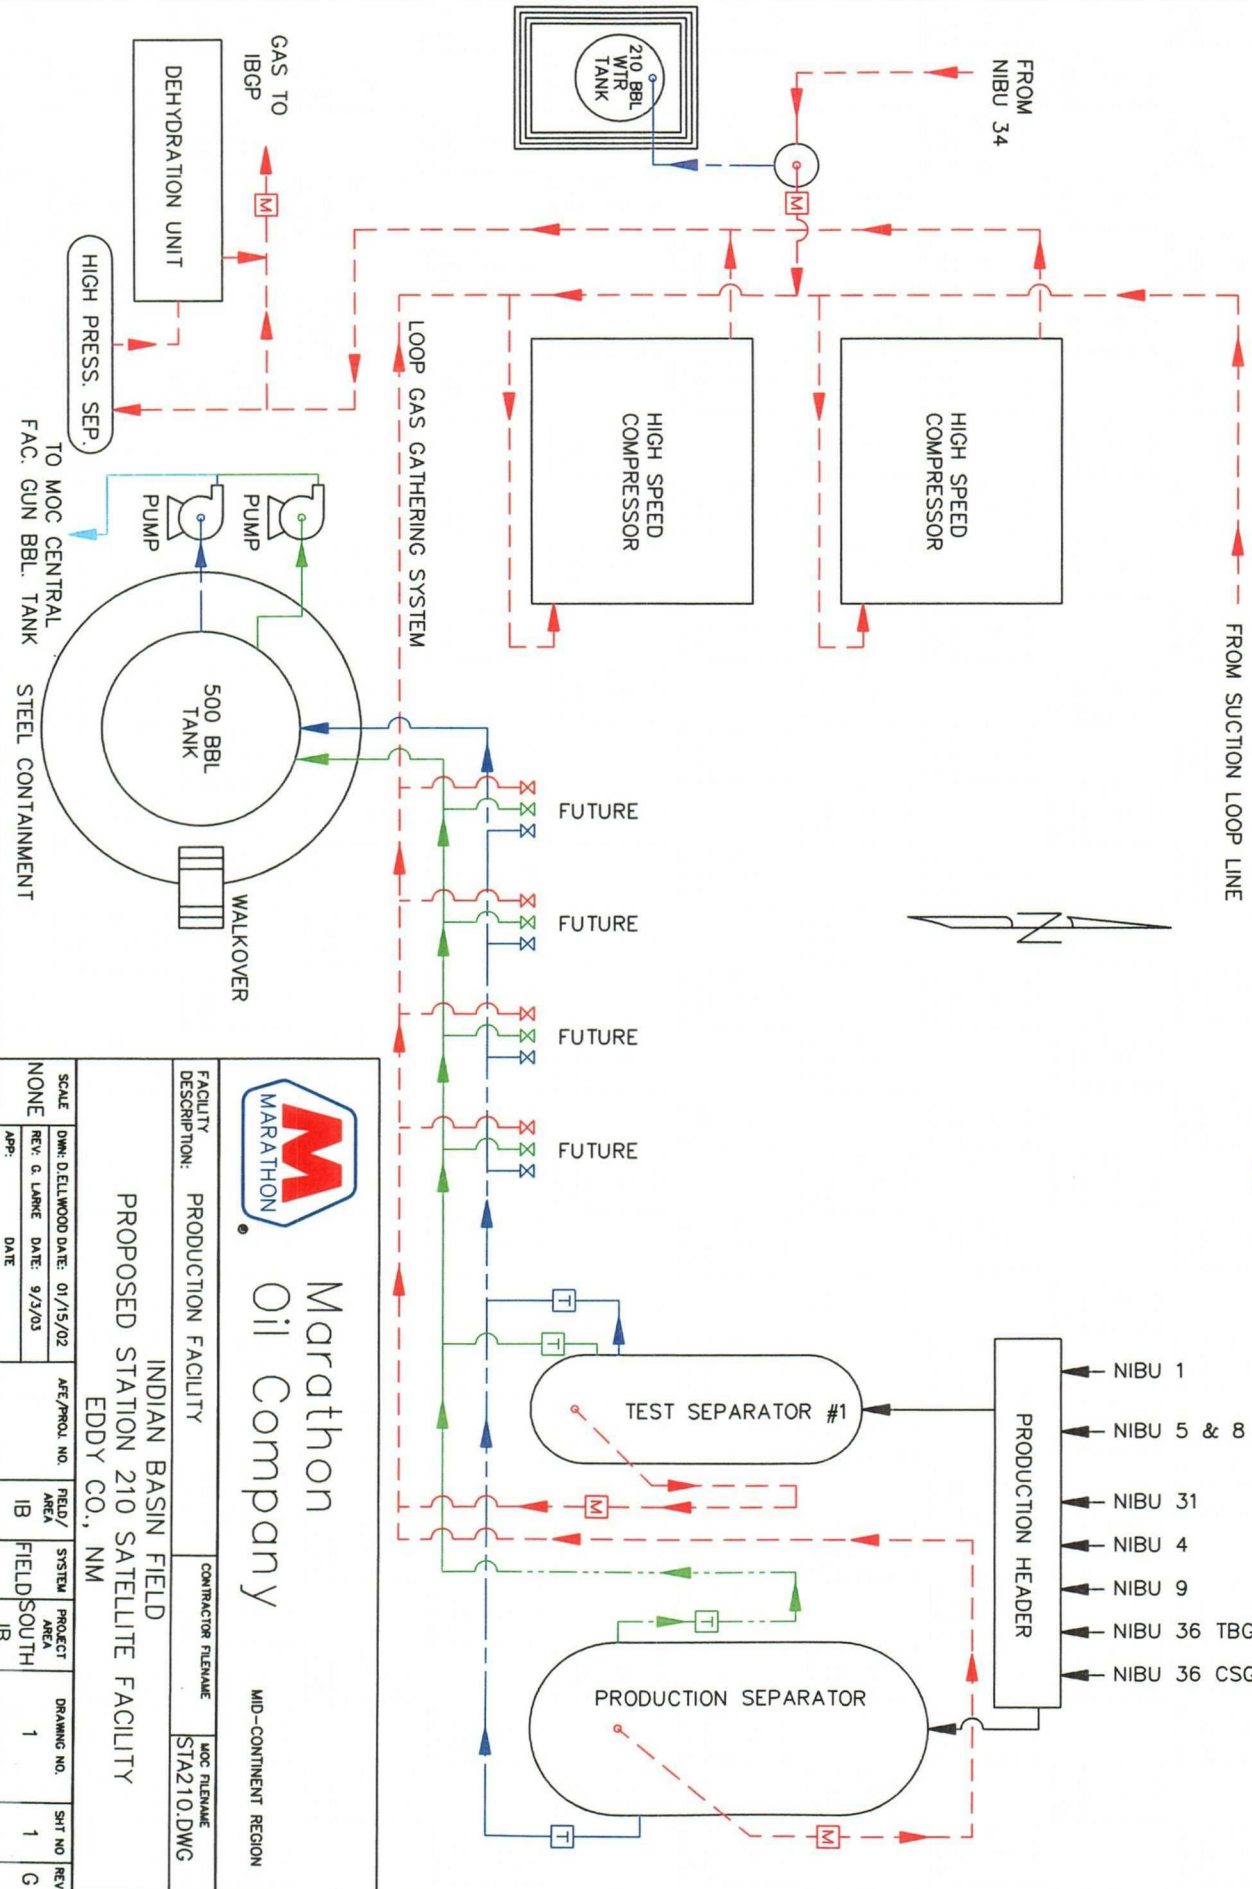

Marathon
Oil Company

MID-CONTINENT REGION

FACILITY DESCRIPTION: PRODUCTION FACILITY


CONTRACTOR FILENAME: STA210.DWG

INDIAN BASIN FIELD
PROPOSED STATION 210 SATELLITE FACILITY
EDDY CO., NM

SCALE	DWG. DATE	REV. DATE	APP.	DATE	APP. NO.	FIELD AREA	SYSTEM AREA	PROJECT AREA	DRAWING NO.	SHT NO.	REV.
NONE	01/15/02	9/3/03				IB	SOUTH	IB	1	1	G


MARATHON OIL COMPANY
 SERVING WELLS: INDIAN BASIN A #2, #3, #4, FED. IBA GC #2, FED. IBA #1, NIBU #32
 STATION NO: 215
 1650' FSL & 1650' FWL
 SEC. 15, T-21-S, R-23-E
 NM 05612A
 EDDY CO. N.M.

THE FACILITY IS SUBJECT
 TO THE SITE SECURITY PLAN FOR
 THE INDIAN BASIN FIELD. THE
 PLAN IS LOCATED AT:
 MARATHON OIL CO.
 329 MARATHON RD.
 LAKEWOOD, NM 88259

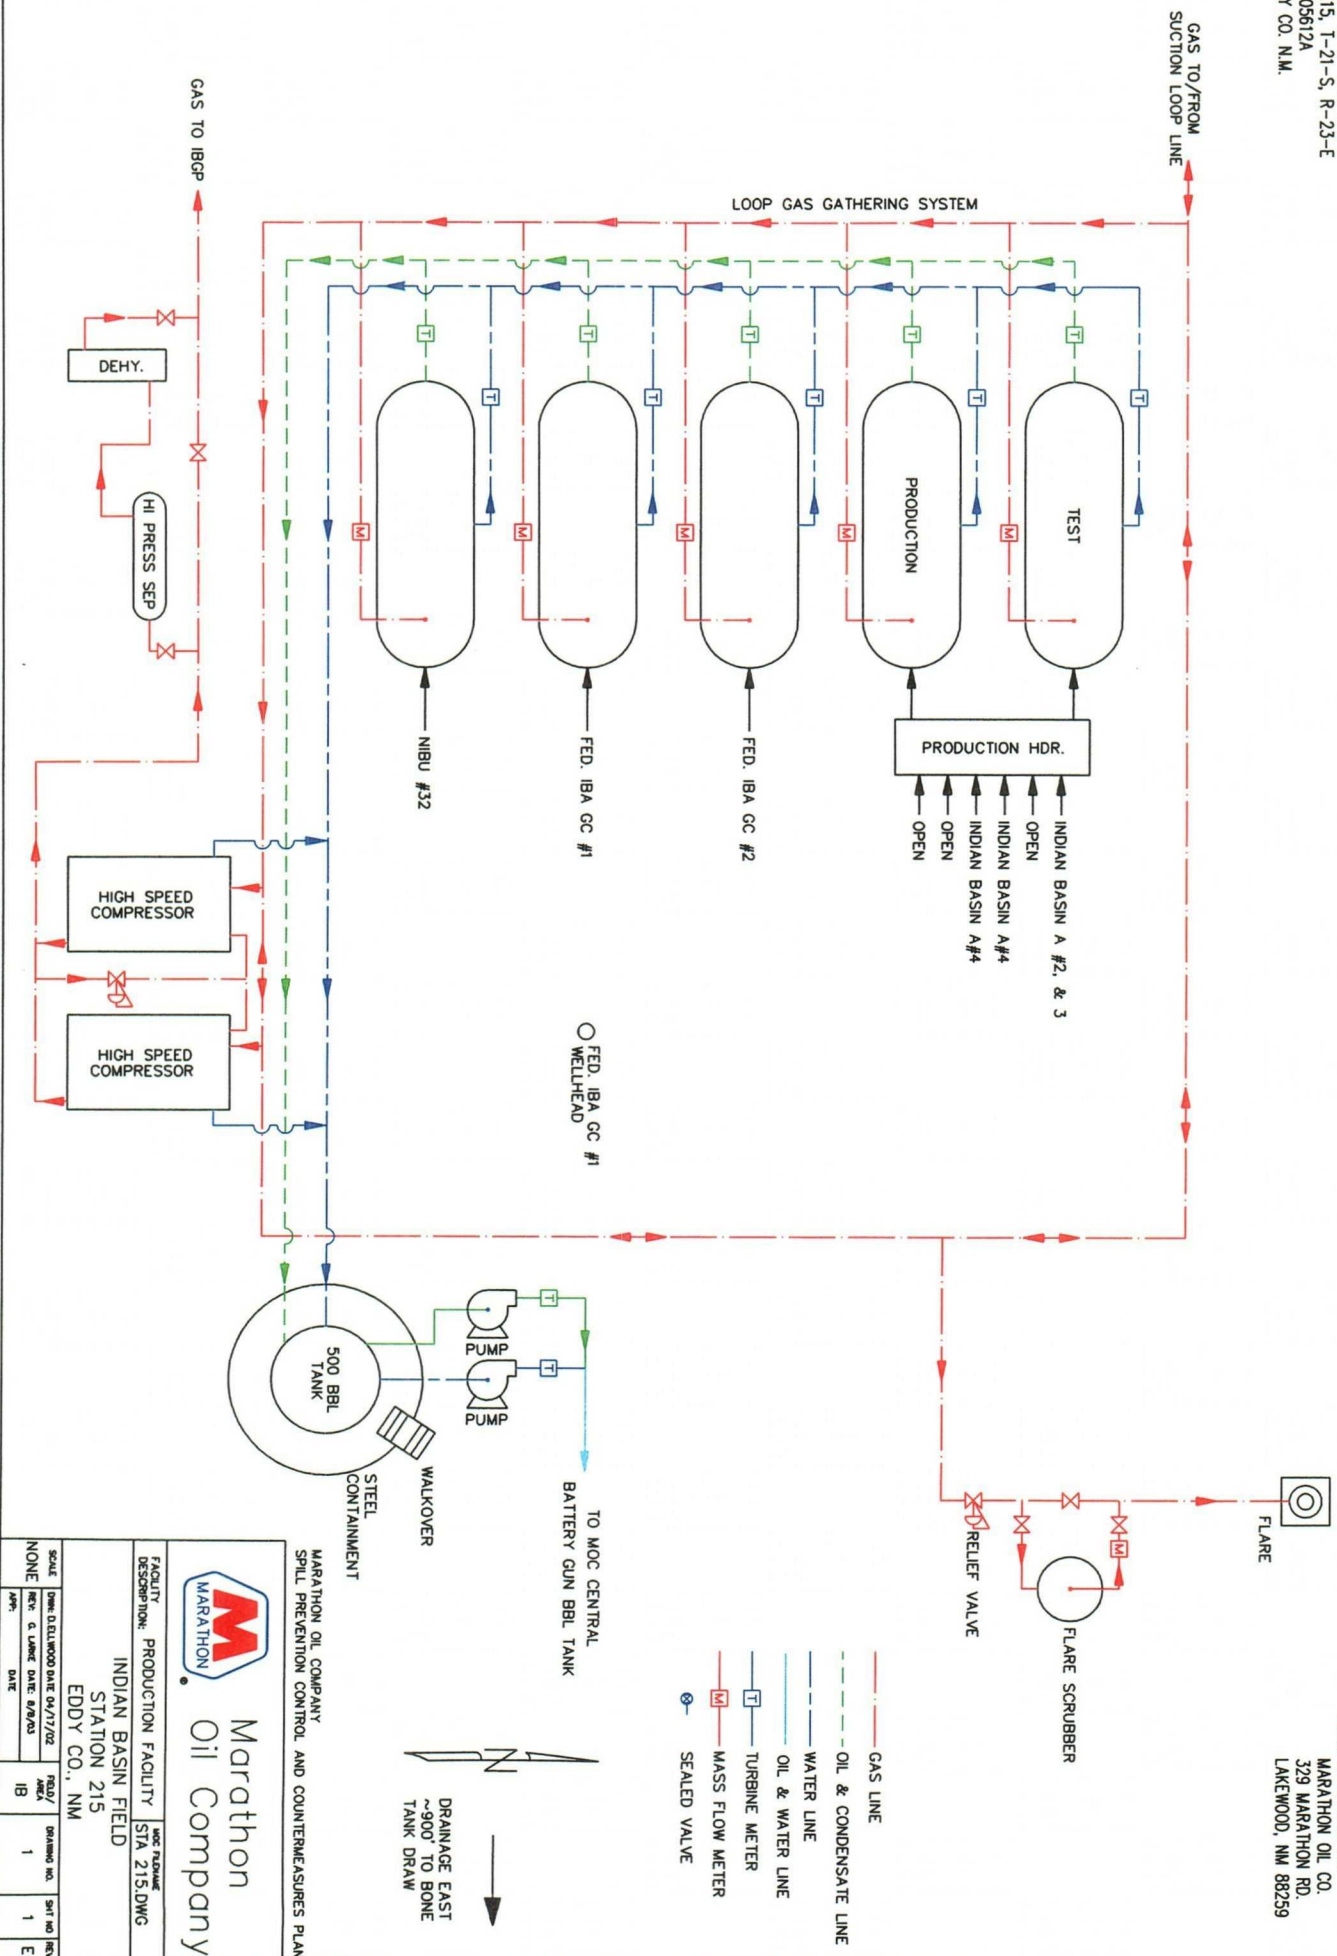

		MARATHON OIL COMPANY STATION 215	
		INDIAN BASIN FIELD EDDY CO., NM	
SCALE NONE	DATE 04/17/02	REV. 1	DATE 04/17/02
DRG. NO. 215	DATE 04/17/02	REV. 1	DATE 04/17/02

MARATHON OIL COMPANY
SERVING WELLS: INDIAN BASIN C #1, 2 & 3,
AND INDIAN BASIN A #1
STATION NO. 226 (SIB)
1650' FNL & 1650' FNL
UL #1, SEC. 26, T-21-S, R-23-E
NM 070522-A
EDDY CO. N.M.

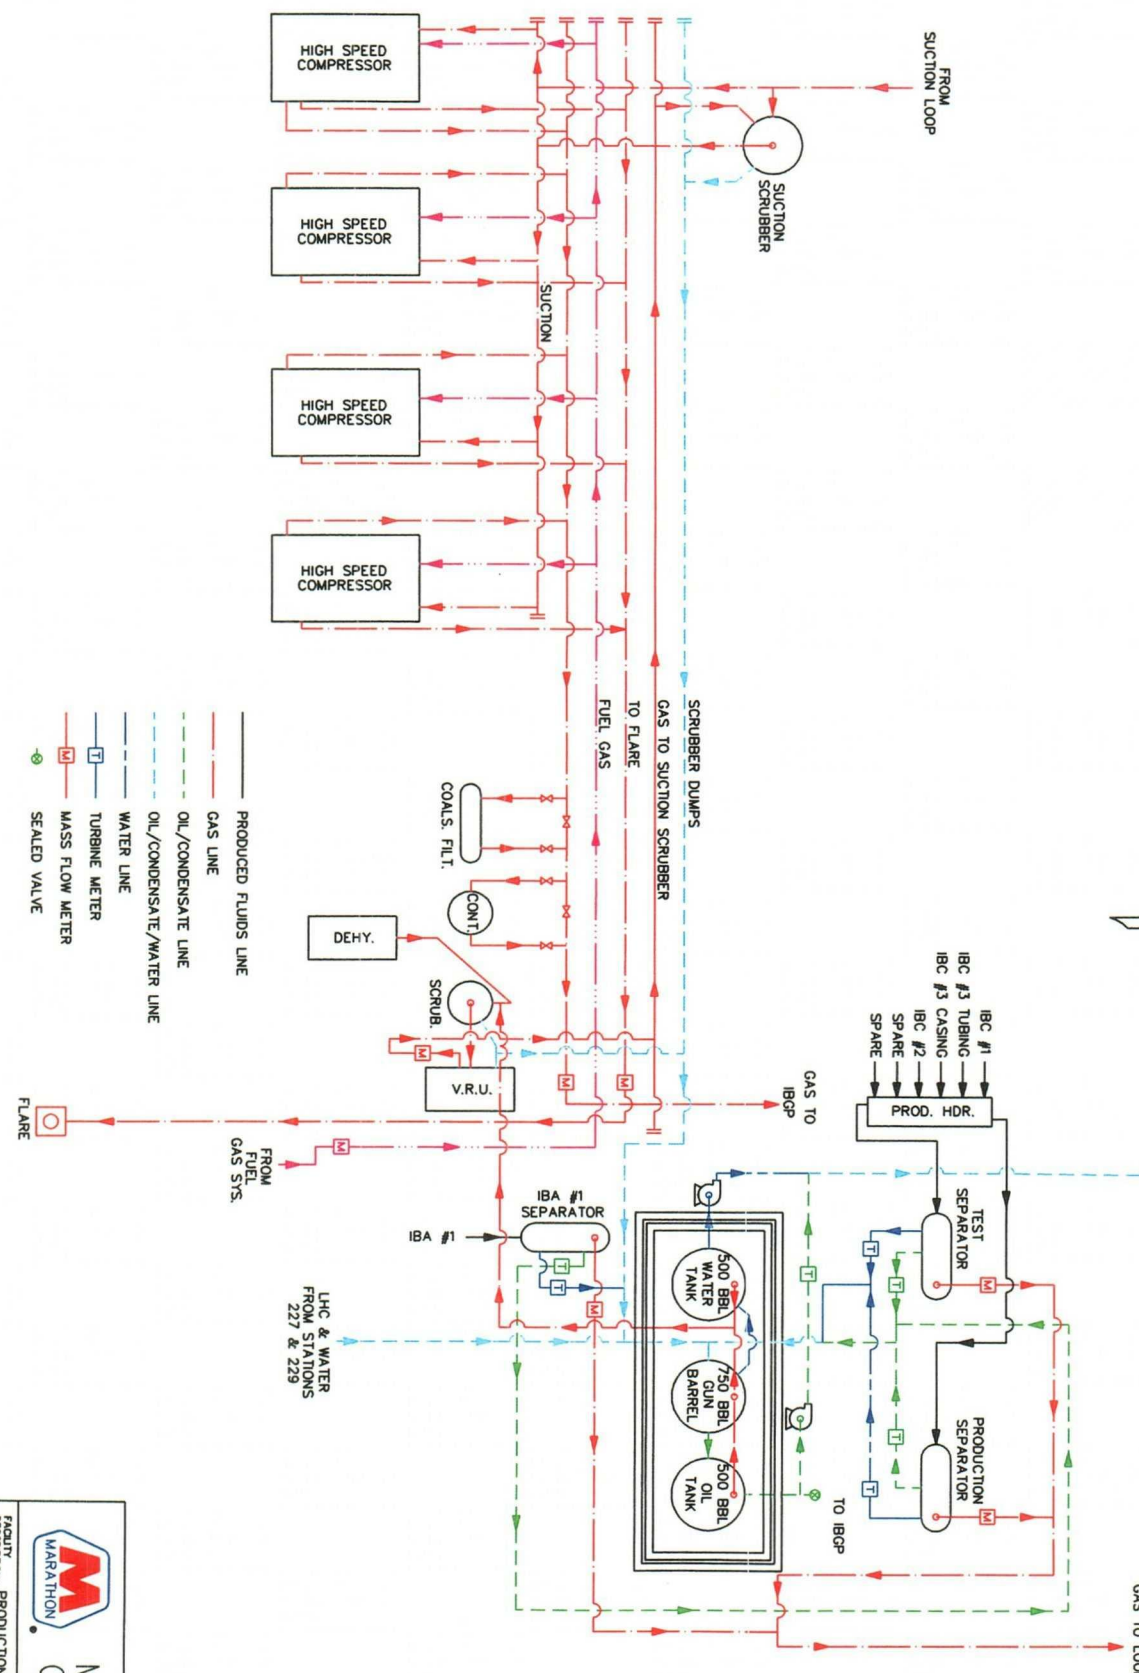

THE FACILITY IS SUBJECT
TO THE SITE SECURITY PLAN FOR
THE INDIAN BASIN FIELD. THE
PLAN IS LOCATED AT:
MARATHON OIL CO.
329 MARATHON RD.
LAKEWOOD, NM 88259


Marathon
Oil Company

FACILITY: PRODUCTION FACILITY STA226.DWG
INDIAN BASIN FIELD
STATION 226 (SIB)
EDDY CO., NM

SCALE	DATE	BY	CHKD	APP'D	DATE	BY	CHKD	APP'D	DATE
NONE									

MARATHON OIL COMPANY
SERVING WELLS: INDIAN BASIN "E" 1 & 2, AND "D" 1 & 2.
STATION NO: 227
1650' FSL & 1650' FWL
SEC. 27 T- 21 -S, R- 23 -E
NM 070522A
EDDY CO. N.M.

THE FACILITY IS SUBJECT
TO THE SITE SECURITY PLAN FOR
THE INDIAN BASIN FIELD. THE
PLAN IS LOCATED AT:
MARATHON OIL CO.
329 MARATHON RD.
LAKEWOOD, NM 88259

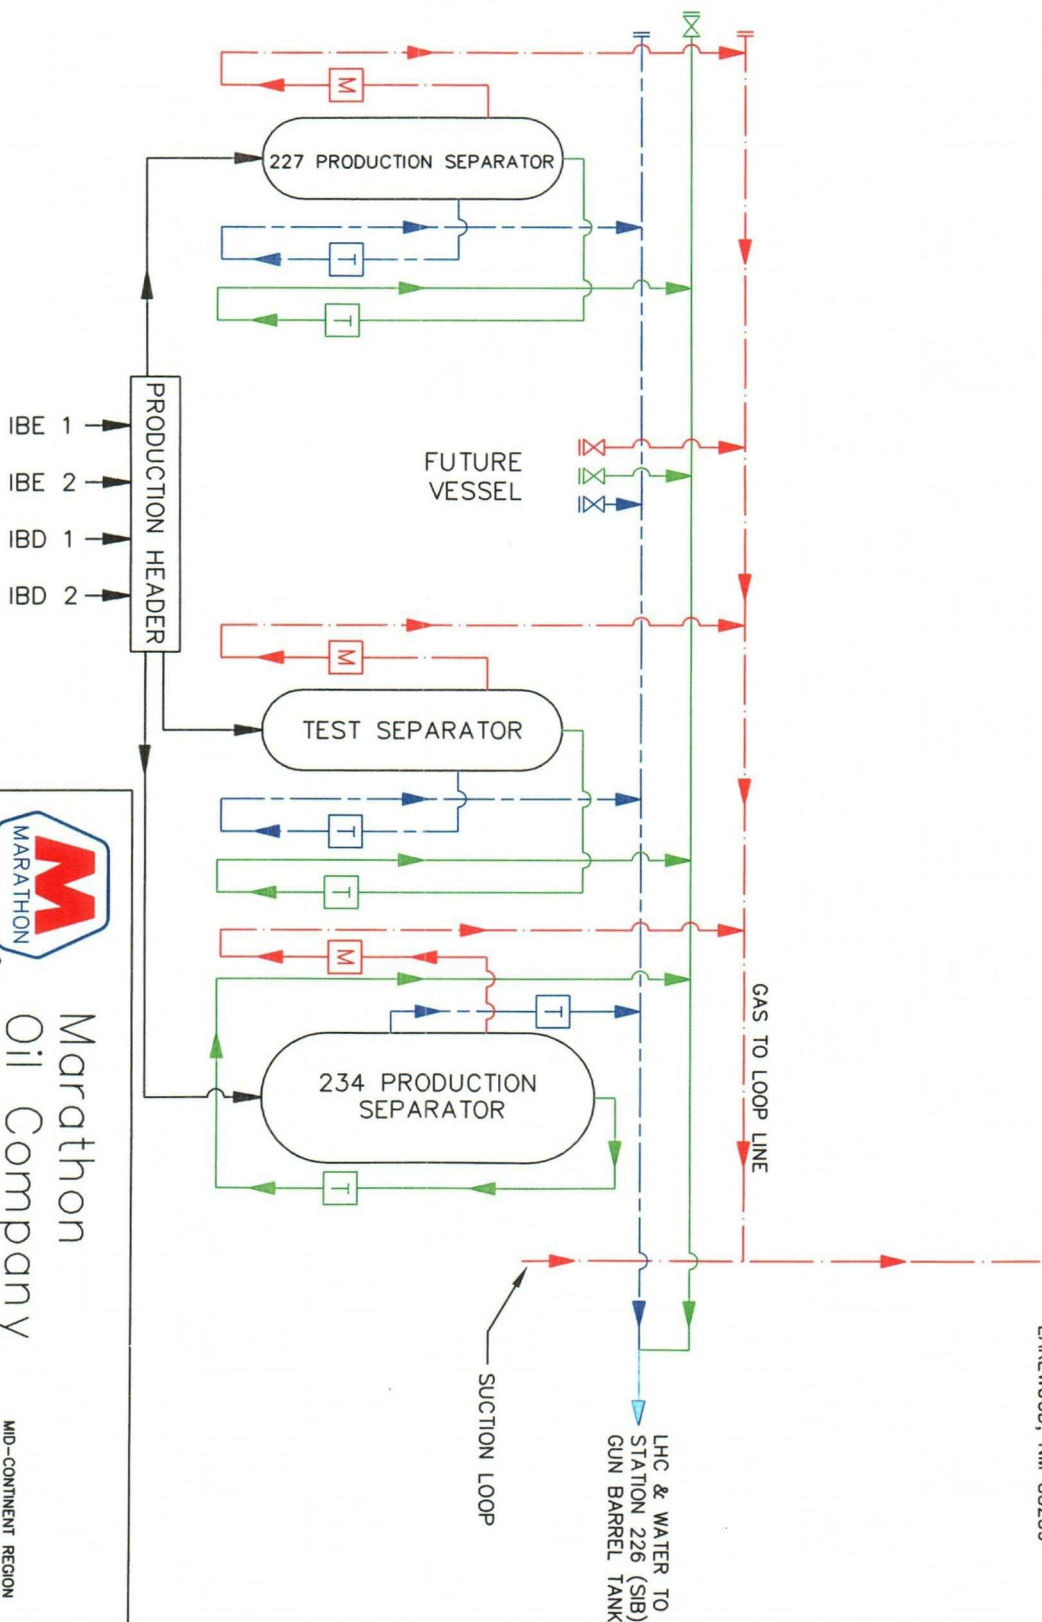

TURBINE METER [T]
MASS FLOW METER [M]
GAS LINE
CONDENSATE LINE
WATER LINE



Marathon
Oil Company

MID-CONTINENT REGION

FACILITY DESCRIPTION: SATELLITE PRODUCTION FACILITY CONTRACTOR FILENAME: MOC FILENAME: STA227.DWG


INDIAN BASIN FIELD

STATION 227 SATELLITE PRODUCTION FACILITY DIAGRAM

EDDY CO., NM

SCALE	DWG: D. ELLWOOD DATE 10/30/01	A/E: PROJ. NO.	FIELD/ AREA	SYSTEM	PROJECT AREA	DRAWING NO.	SHT NO	REV
NONE	CHKD: DATE		IB	FIELD		1	1	G
	APP: DATE							

MARATHON OIL COMPANY
 STATION NO.: 229
 SERVING WELLS: FEDERAL IBC GC #1 & #2
 UL "J", 1700' FSL & 1550' FEL
 SEC.29 T-21-S, R-23-E
 EDDY CO. NM.

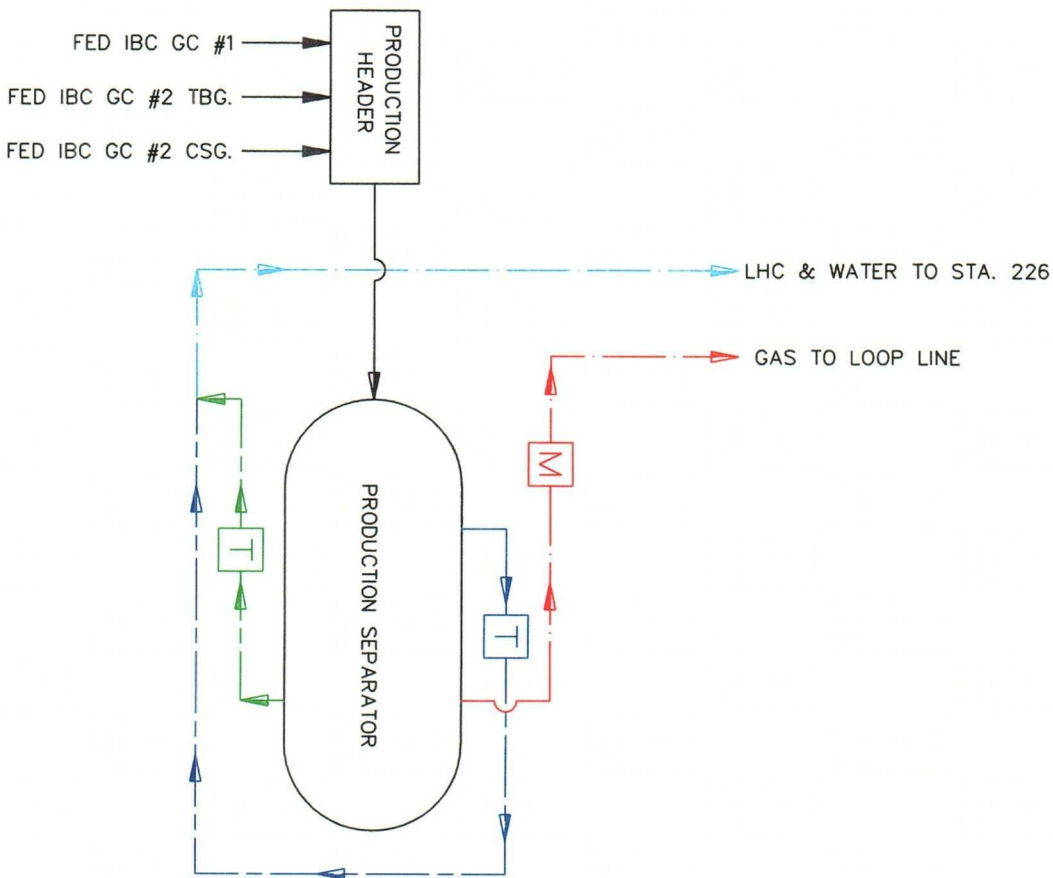

THE FACILITY IS SUBJECT
 TO THE SITE SECURITY PLAN FOR
 THE INDIAN BASIN FIELD. THE
 PLAN IS LOCATED AT:
 MARATHON OIL CO.
 329 MARATHON RD.
 LAKEWOOD, NM 88259



Marathon
 Oil Company

FACILITY DESCRIPTION: PRODUCTION FACILITY MOC FILENAME: STA229.dwg

INDIAN BASIN FIELD
 229 SATELLITE FACILITY
 EDDY CO., NM


SCALE	DWG: D.ELLWOOD DATE 01/15/02	FIELD/ AREA	DRAWING NO.	SHT NO	REV
NONE	CHKD: DATE	IB	1	1	C
	APP: DATE				

MARATHON OIL COMPANY
SERVING WELLS: FEDERAL C "35" #1, #2, #3 & #4
STATION 235
800' FSL & 800' FWL
SEC. 35 T-21-S, R-23-E
NM 06953
EDDY CO. N.M.

LHC & WTR
TO MOC
CENTRAL
FACILITY
GUN BARREL
TANK

LOOP GAS GATHERING SYSTEM

THE FACILITY IS SUBJECT
TO THE SITE SECURITY PLAN FOR
THE INDIAN BASIN FIELD. THE
PLAN IS LOCATED AT:
MARATHON OIL CO.
329 MARATHON RD.
LAKEWOOD, NM 88259

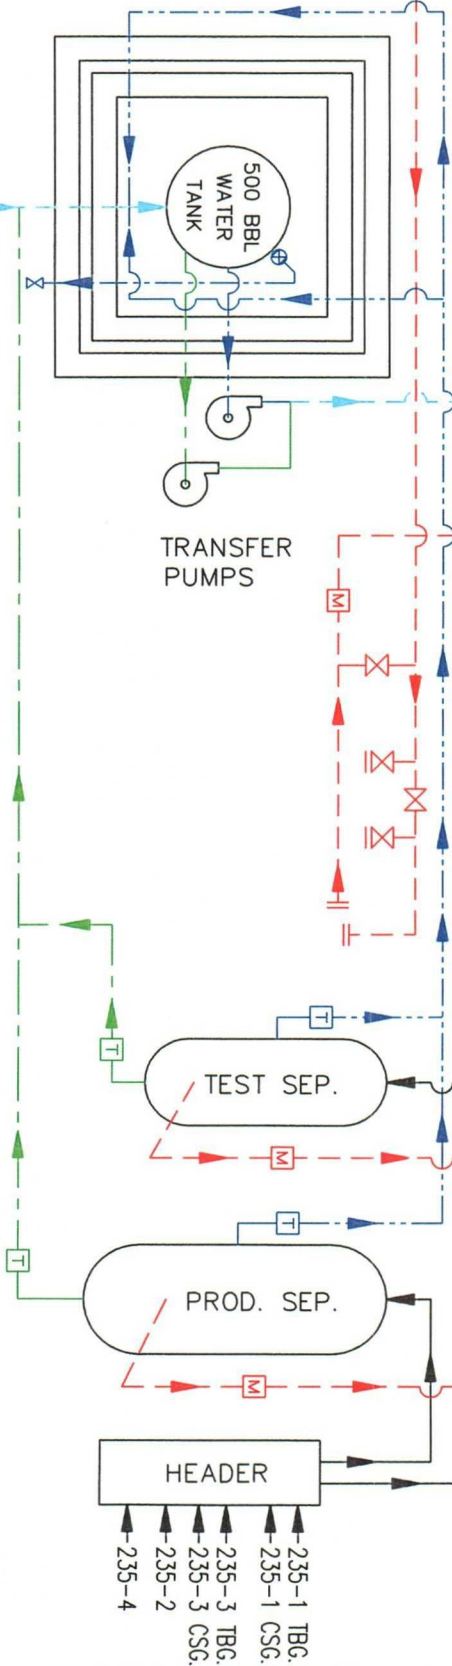

LHC & WATER
FROM STATION 311

TRANSFER
PUMPS

TEST SEP.

PROD. SEP.

HEADER

235-1 TBG.
235-1 CSG.
235-3 TBG.
235-3 CSG.
235-2
235-4



- GAS LINE
- OIL LINE
- WATER LINE
- PRODUCED FLUIDS
- MASS FLOW METER
- TURBINE METER
- SEALED VALVE

FED C 35-2
WELLHEAD



Marathon
Oil Company

FACILITY DESCRIPTION: PRODUCTION FACILITY MOC FILENAME: STA235.dwg

INDIAN BASIN FIELD



STATION 235

EDDY CO., NM

SCALE	DATE	FIELD / AREA	DRAWING NO.	SHT NO	REV
NONE	DATE	IB	1	1	D
CHD:	DATE				
APP:	DATE				

MARATHON OIL COMPANY
 STATION NO.: 311 - SMITH FEDERAL
 SERVING WELLS: SMITH FEDERAL WELLS #1, #2 & #3
 UL "F", 1650' FNL & 1650' FWL
 SEC. 11 T-22-S, R-23-E
 NM 0251099-A
 EDDY CO. N.M.


THE FACILITY IS SUBJECT
 TO THE SITE SECURITY PLAN FOR
 THE INDIAN BASIN FIELD. THE
 PLAN IS LOCATED AT:
 MARATHON OIL CO.
 329 MARATHON RD.
 LAKEWOOD, NM 88259

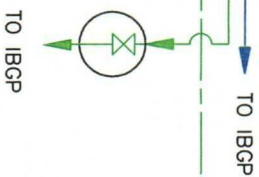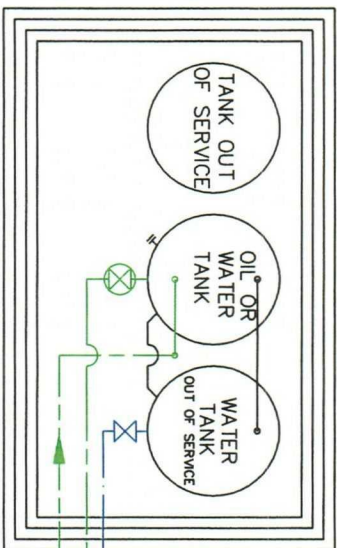

VESSEL POP-OFF LINE


SM.FED 1

 LHC & WATER TO STA. 235
 GAS TO LOOP LINE
 FENCE LINE



TEST SEPARATOR

PROD. SEPARATOR

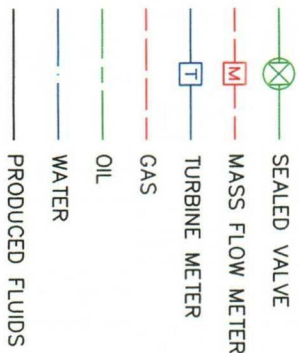



Marathon
 Oil Company

FACILITY DESCRIPTION: PRODUCTION FACILITY
 MOC FILENAME: STA311.DWG

INDIAN BASIN FIELD
 STATION 311
 EDDY CO., NM

SCALE	DWG: DELLWOOD DATE 04/17/02	FIELD/ AREA	DRAWING NO.	SHT NO	REV
NONE	CHKD: DATE	IB	1	1	D
APP: DATE					

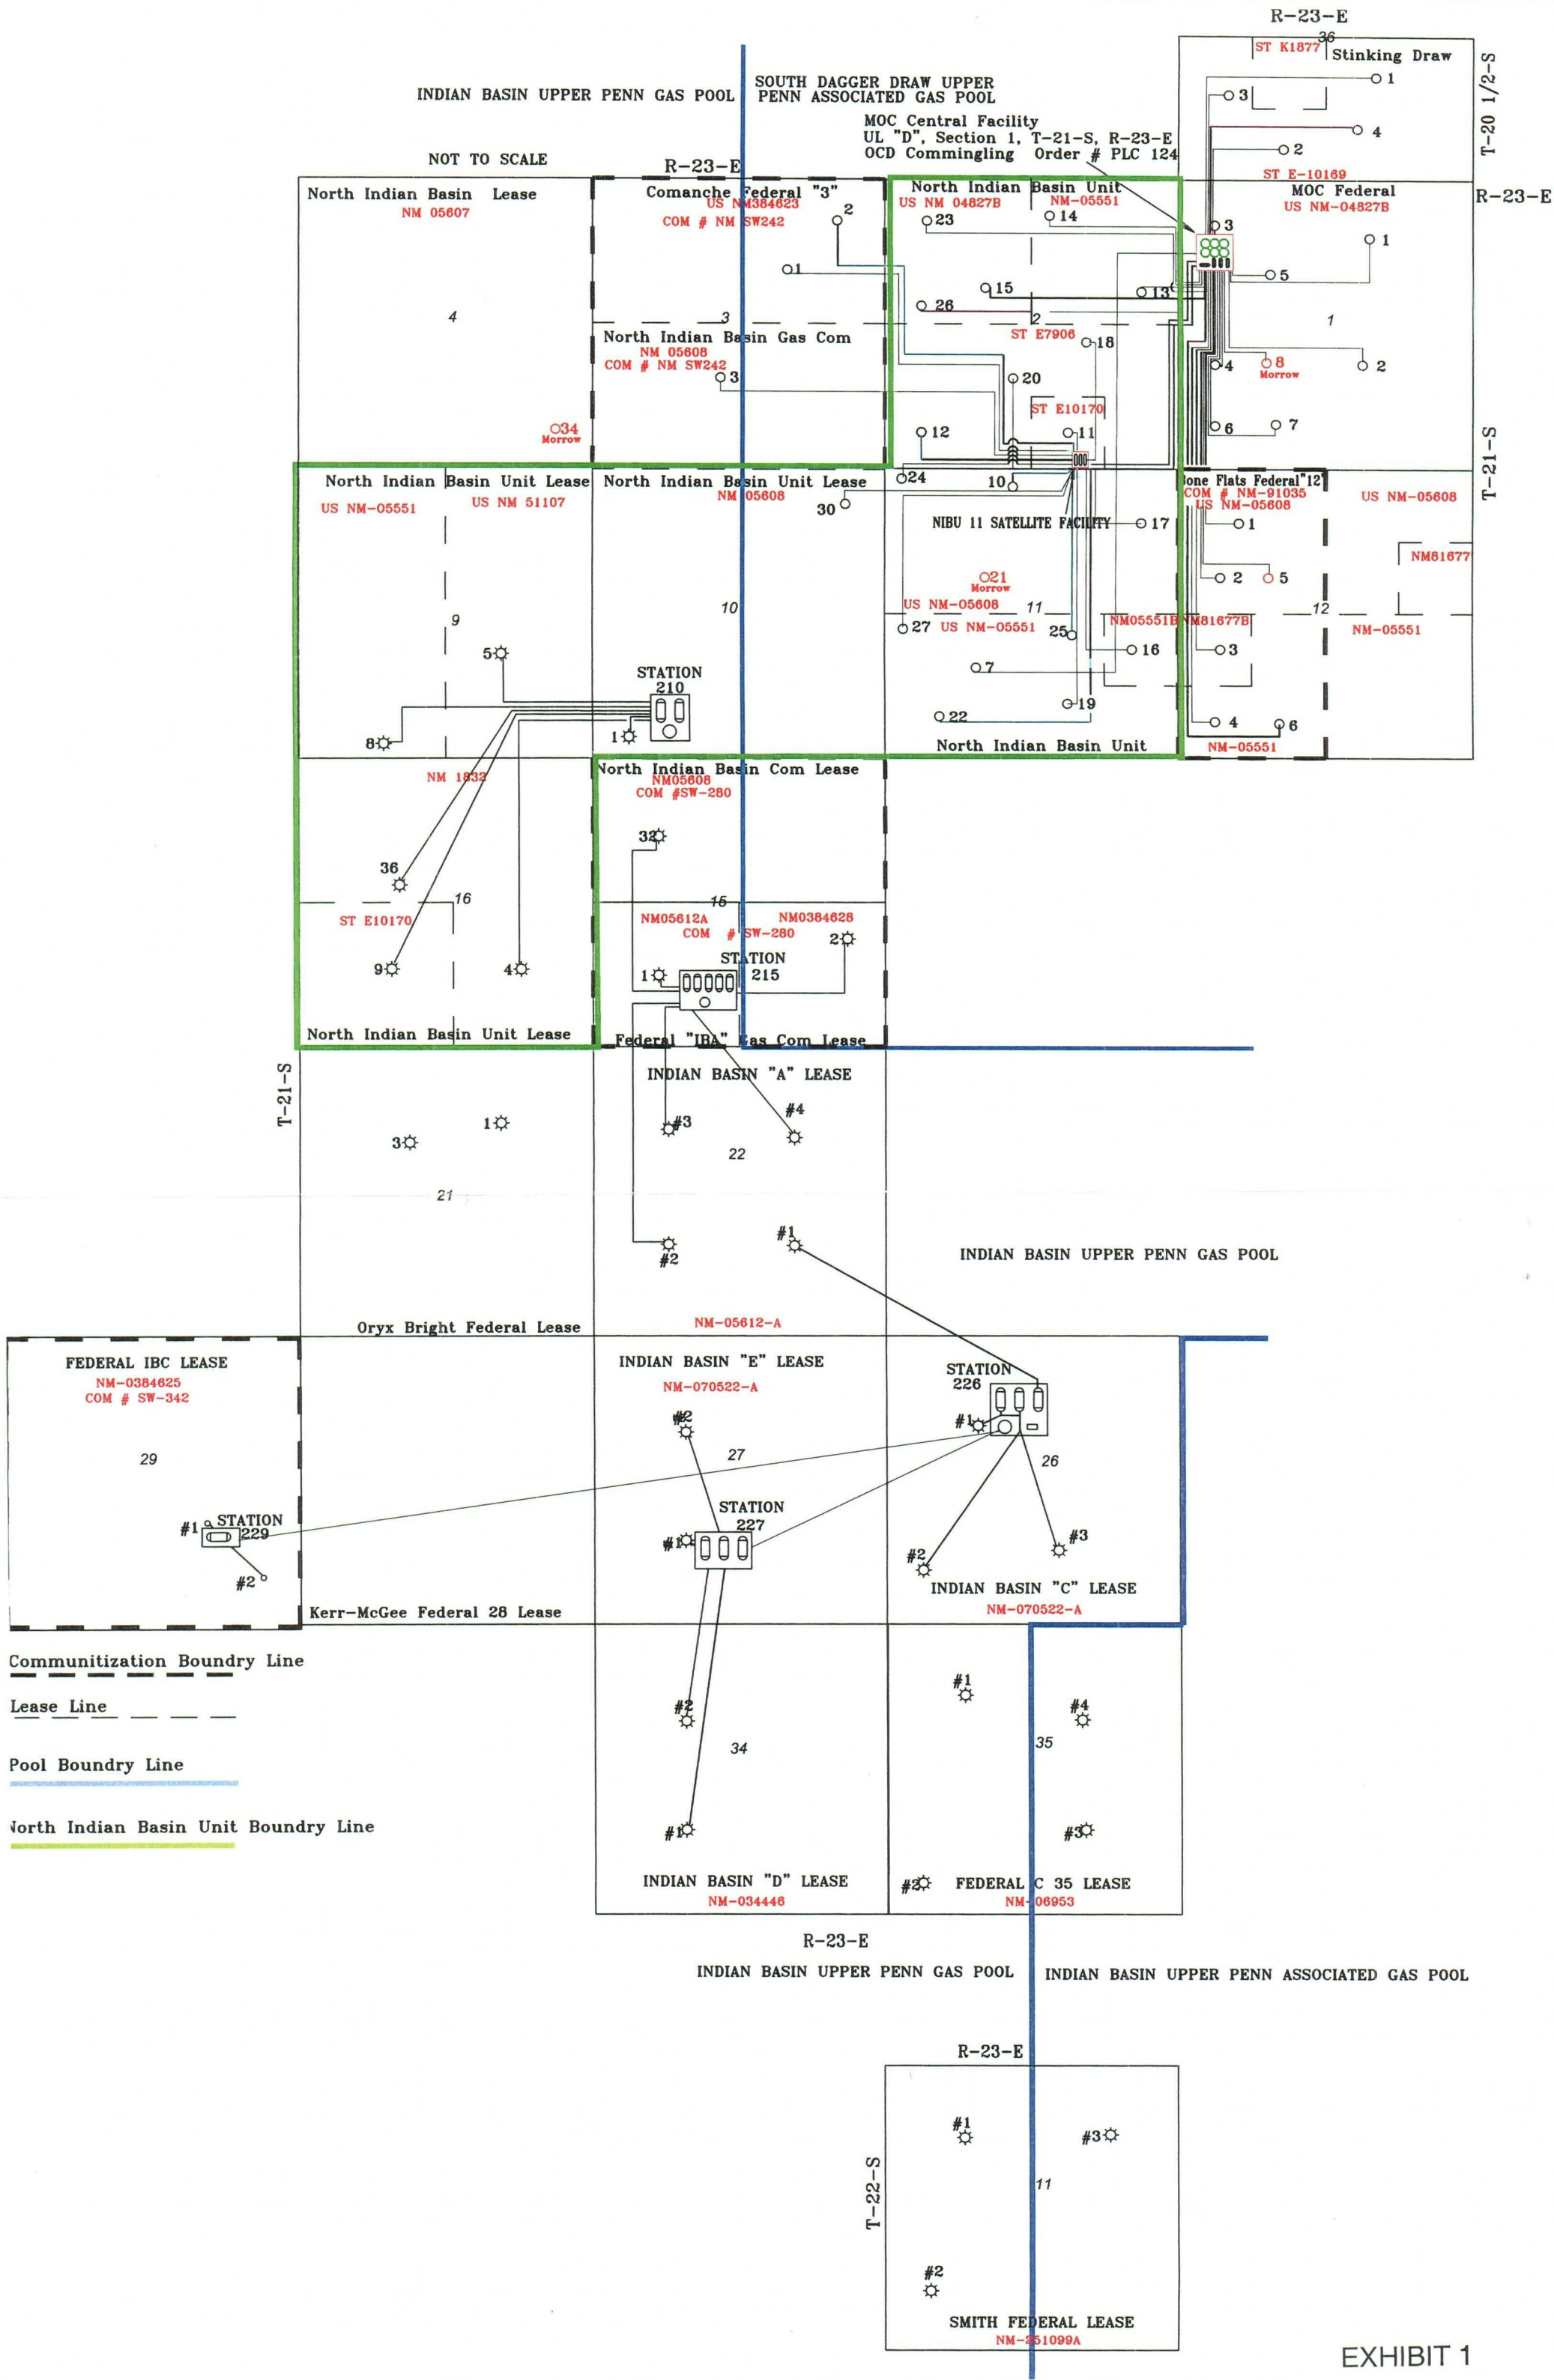

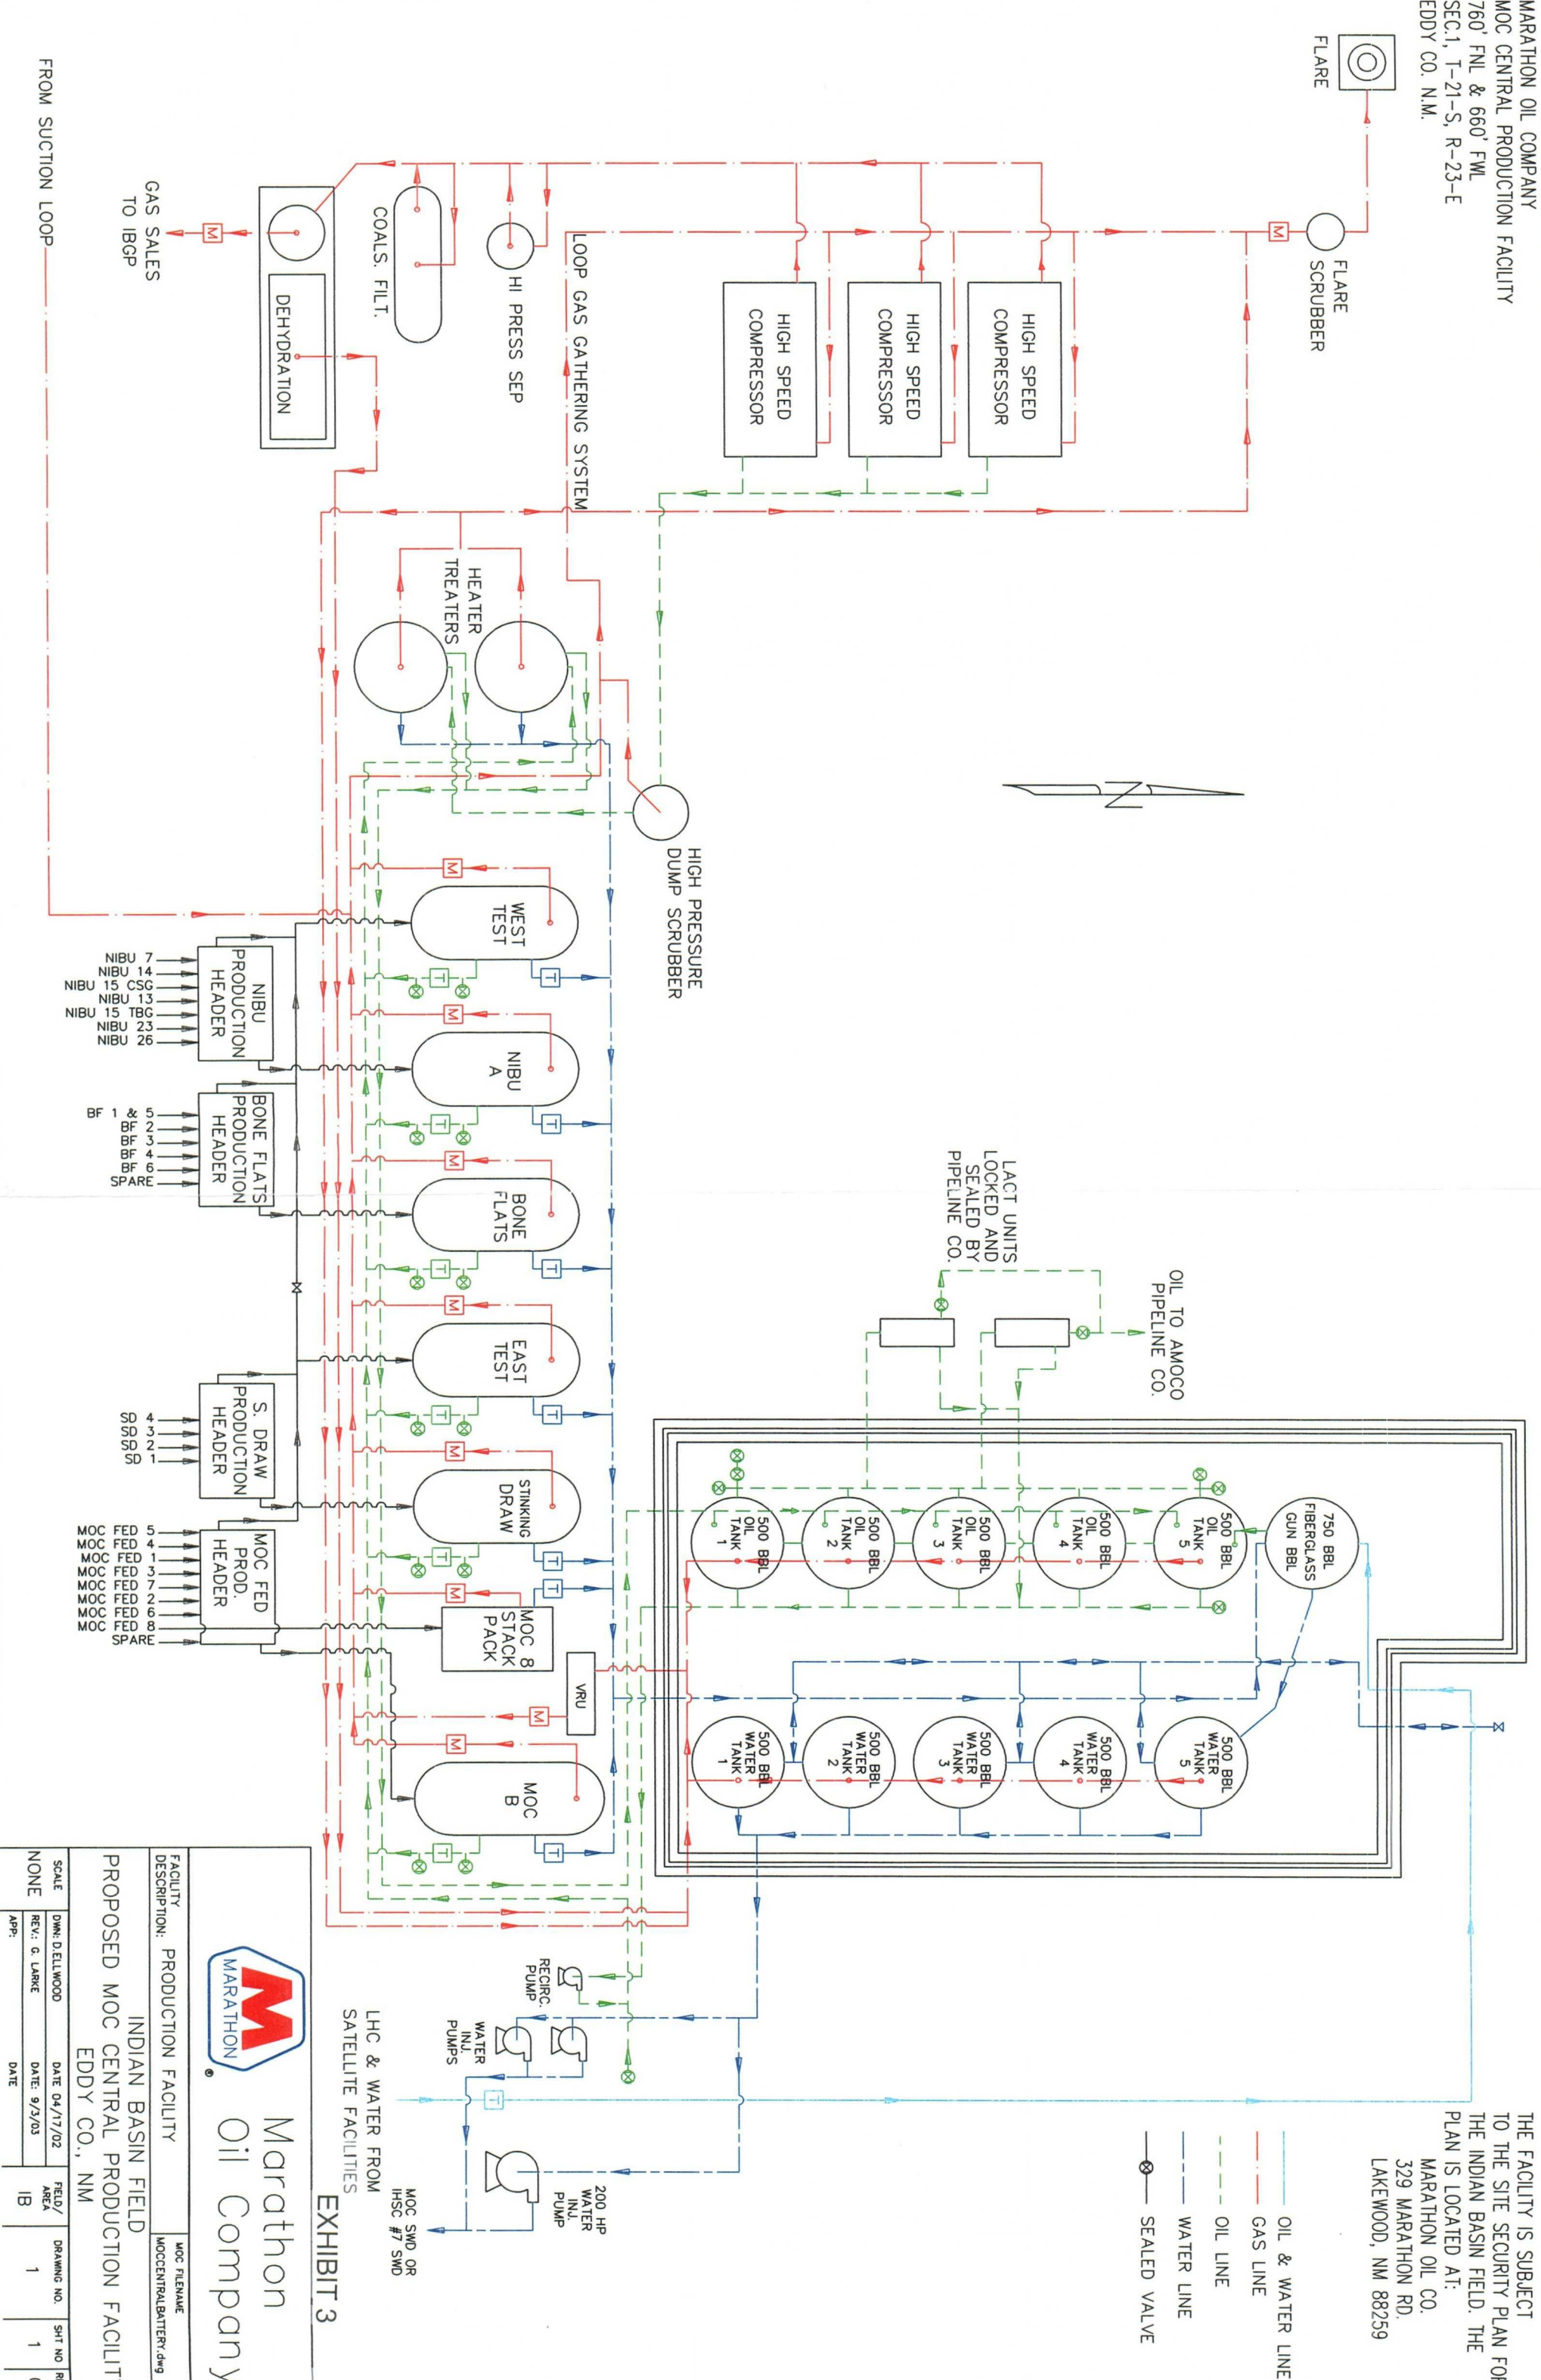


THE FACILITY IS SUBJECT TO THE SITE SECURITY PLAN FOR THE INDIAN BASIN FIELD. THE PLAN IS LOCATED AT:
MARATHON OIL CO.
329 MARATHON RD.
LAKEWOOD, NM 88259



Marathon
Oil Company

FACILITY DESCRIPTION:		MOC FILENAME	
INDIAN BASIN FIELD		MOCENTRALBATTERY.dwg	
PROPOSED MOC CENTRAL PRODUCTION FACILITY			
EDDY CO., NM			
SCALE	DWN: DELLWOOD	DATE: 04/17/02	FIELD/ AREA
NONE	REV: G. LARKE	DATE: 9/3/03	IB
APP:	DATE		
		DRAWING NO.	SHT NO
		1	1
			G

MARATHON OIL COMPANY - NIBU 11 SATELLITE FACILITY
SERVING WELLS: NIBU GC 3, NIBU 10, 11, 12, 16, 17, 18, 19, 20,
21, 22, 24, 25, 27, 30, COMANCHE FED "3" NO's 1 AND 2.
UL "0", SEC.2, T-21-S, R-23-E
NM 05551
EDDY CO. N.M.

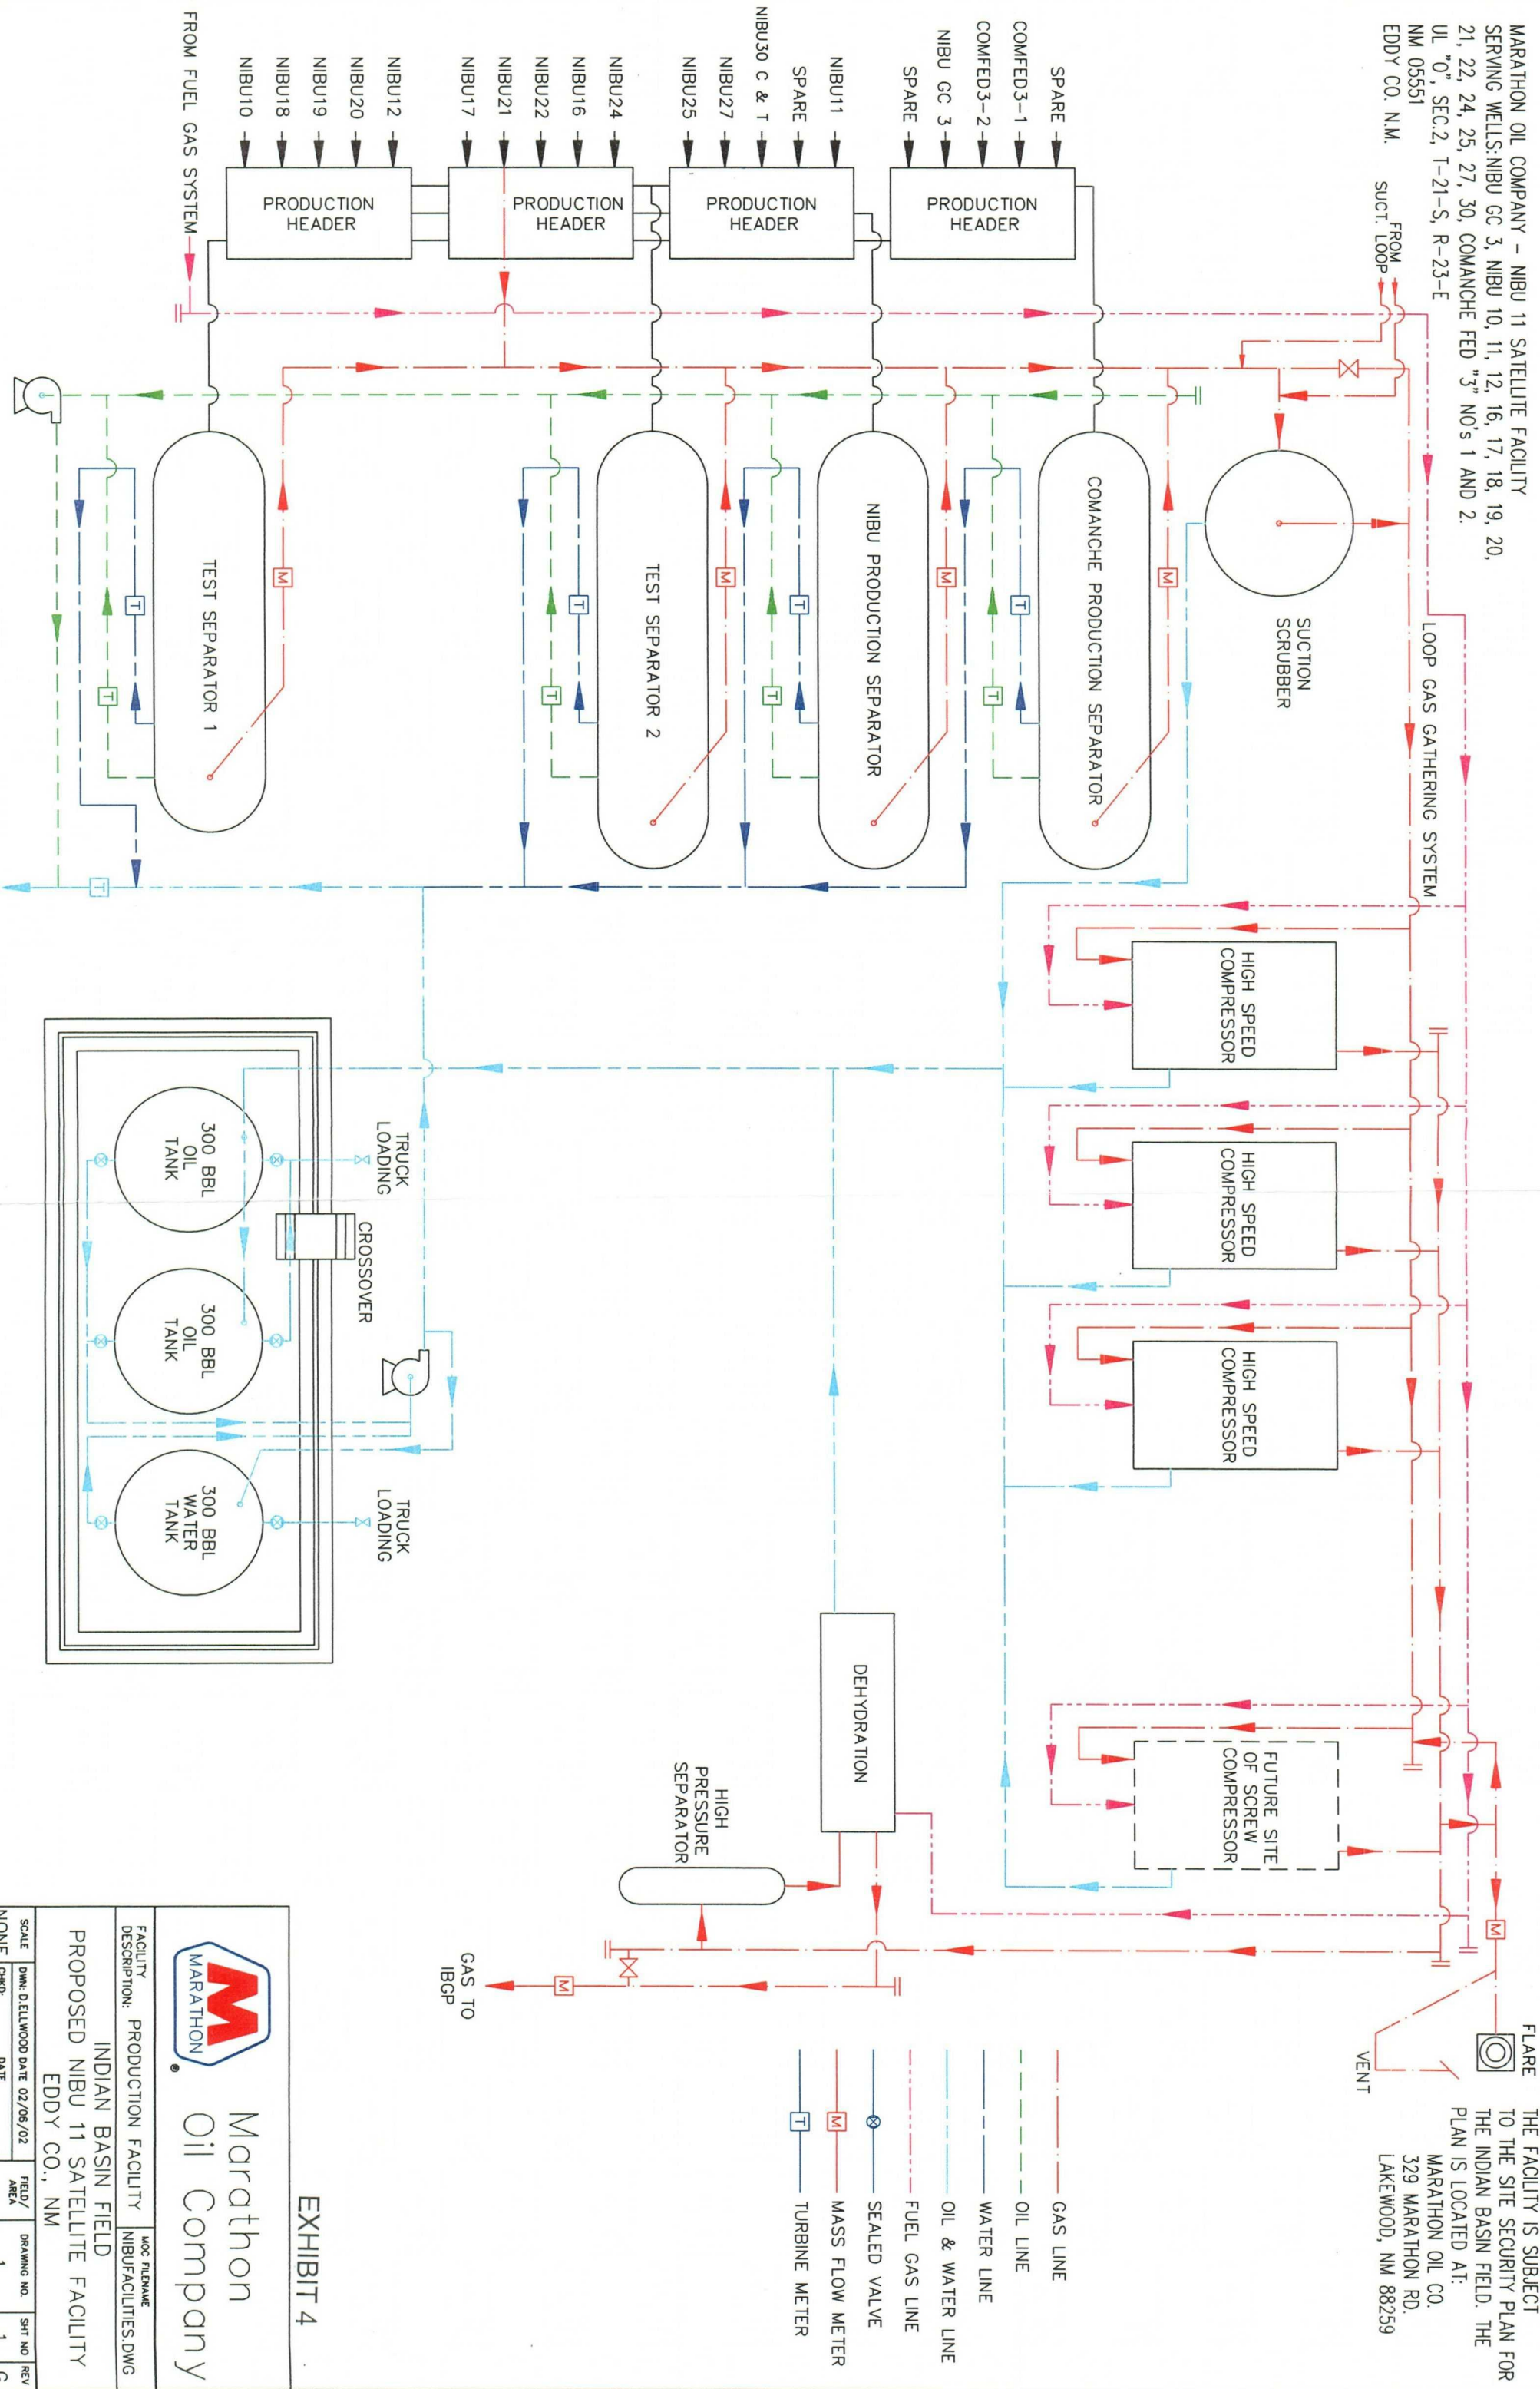

FLARE
THE FACILITY IS SUBJECT
TO THE SITE SECURITY PLAN FOR
THE INDIAN BASIN FIELD. THE
PLAN IS LOCATED AT:
MARATHON OIL CO.
329 MARATHON RD.
LAKEWOOD, NM 88259

EXHIBIT 4



Marathon
Oil Company

FACILITY DESCRIPTION: PRODUCTION FACILITY MOC FILENAME: NIBUFACILITIES.DWG

INDIAN BASIN FIELD
PROPOSED NIBU 11 SATELLITE FACILITY
EDDY CO., NM

SCALE	DWG: D ELLWOOD DATE 02/05/02	FIELD/ AREA	DRAWING NO.	SHT NO	REV
NONE	CHKD: DATE	IB	1	1	G
App:	DATE				